



DATE	
BY	
REVISIONS	
PLANNING	
DESIGN	
CONSTRUCTION	
NO.	
NOTE BOOK	
ALIGNMENT CHECKED	
BY: C. W. WAY	
NO.	

DATE	
BY	
REVISIONS	
PROFILE	
DESIGN	
CONSTRUCTION	
NO.	
NOTE BOOK	
GRADES CHECKED	
BY: C. W. WAY	
NO.	

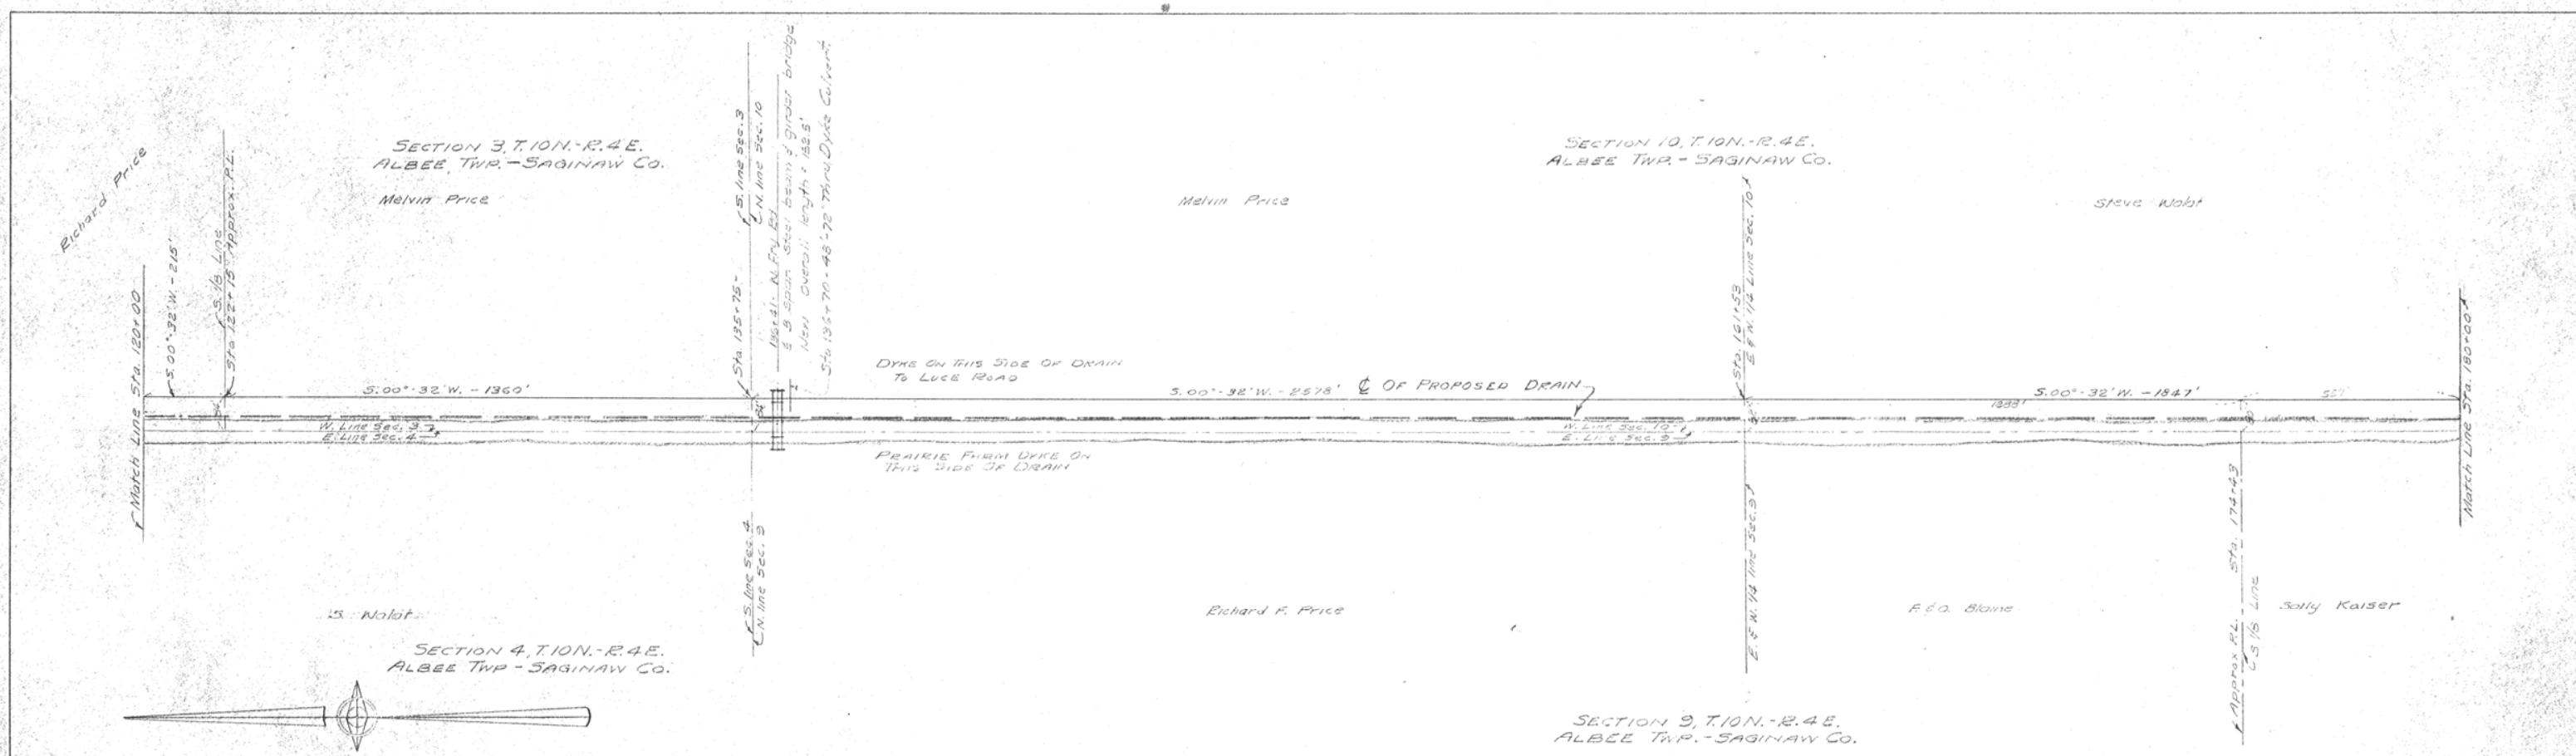

Station stakes and grade hubs are located to the right or left of the centerline of drain looking upstream as follows:  
 Sta 120+00 to Sta 135+75 ----- 78' Left  
 Sta 135+75 to Sta 187+30 ----- 04' Left

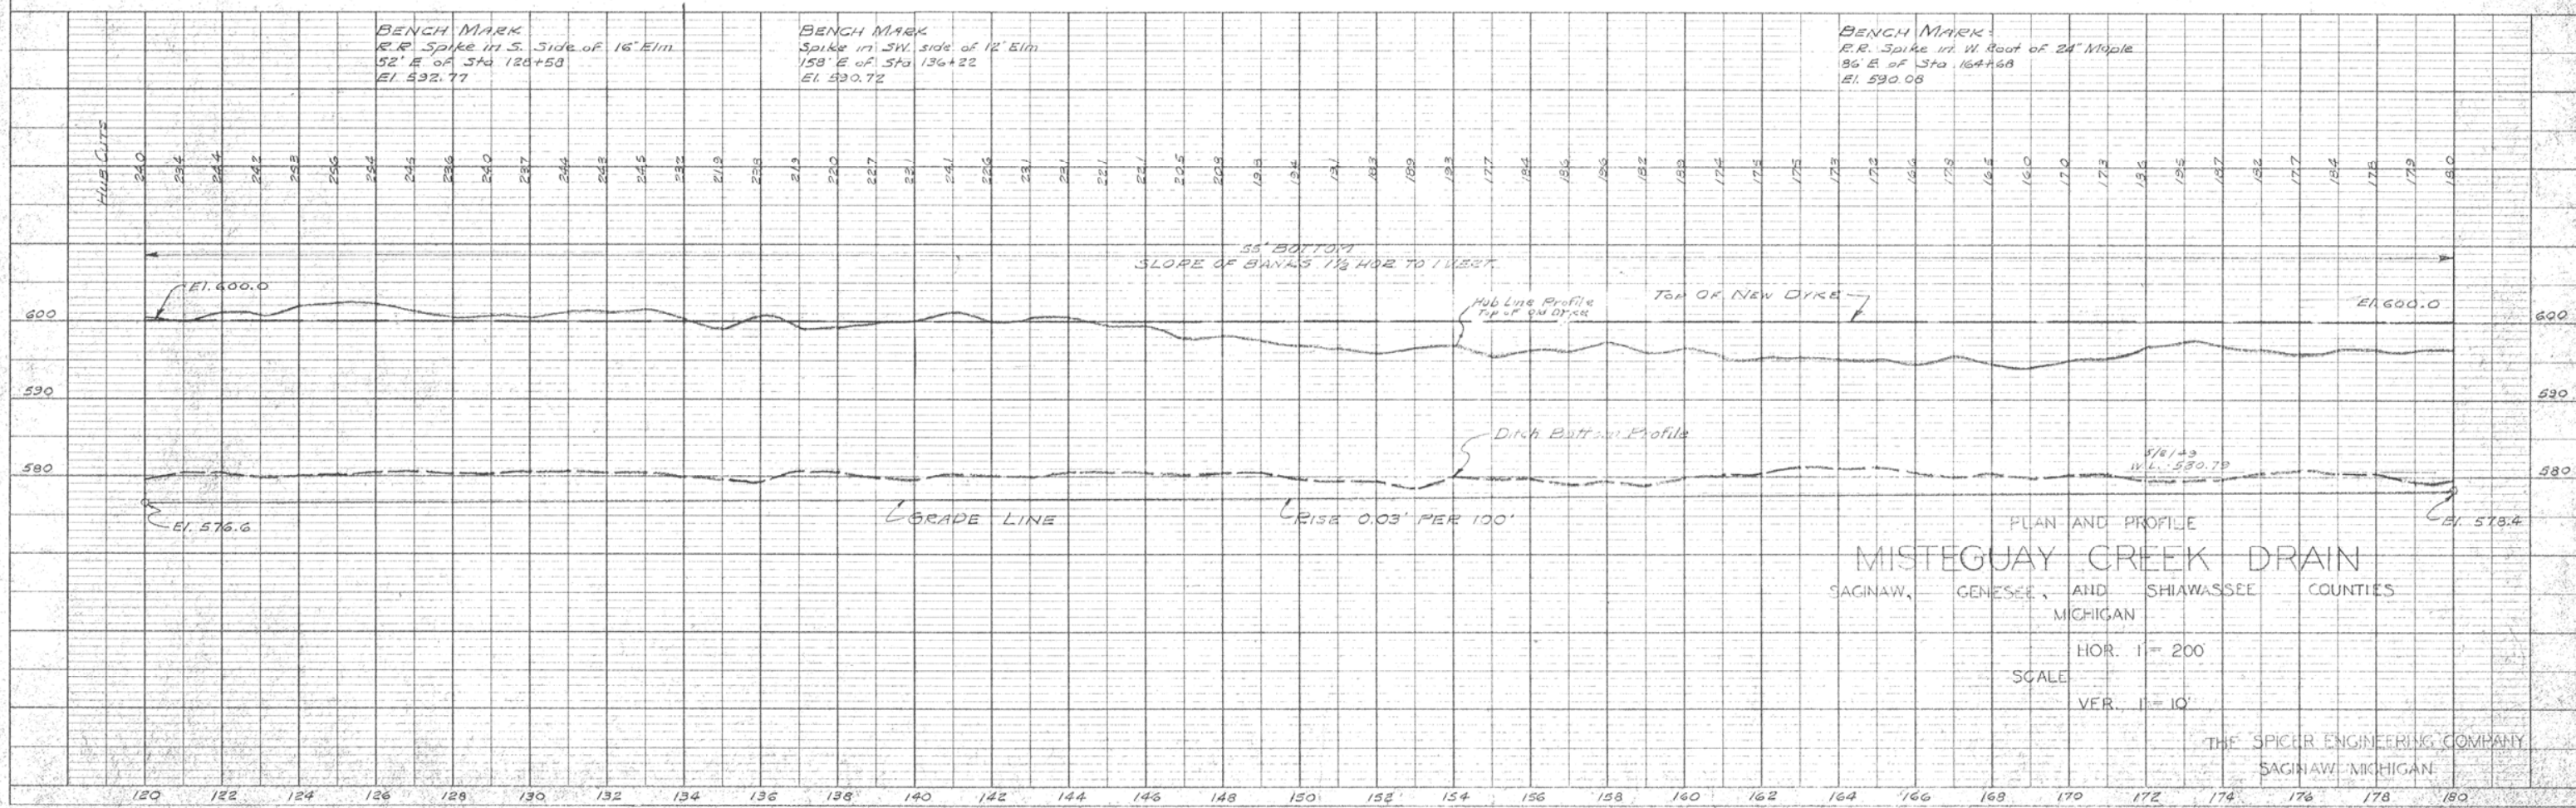

PLAN AND PROFILE  
**MISTEGUAY CREEK DRAIN**  
 SAGINAW, GENESEE, AND SHIawassee COUNTIES  
 MICHIGAN

HOR. 1" = 200'  
 SCALE  
 VER. 1" = 10'

THE SPICER ENGINEERING COMPANY  
 SAGINAW, MICHIGAN