


DATE	
BY	
APPROVED	
PLOTTED	
CHECKED	
STRUCTURE NOTATION CHECKED	
NO.	


DATE	
BY	
APPROVED	
PLOTTED	
CHECKED	
STRUCTURE NOTATION CHECKED	
NO.	

SECTION 22, T. 10N., R. 4E.
ALBEE TWP. - SAGINAW CO.

SECTION 21, T. 10N., R. 4E.
ALBEE TWP. - SAGINAW CO.

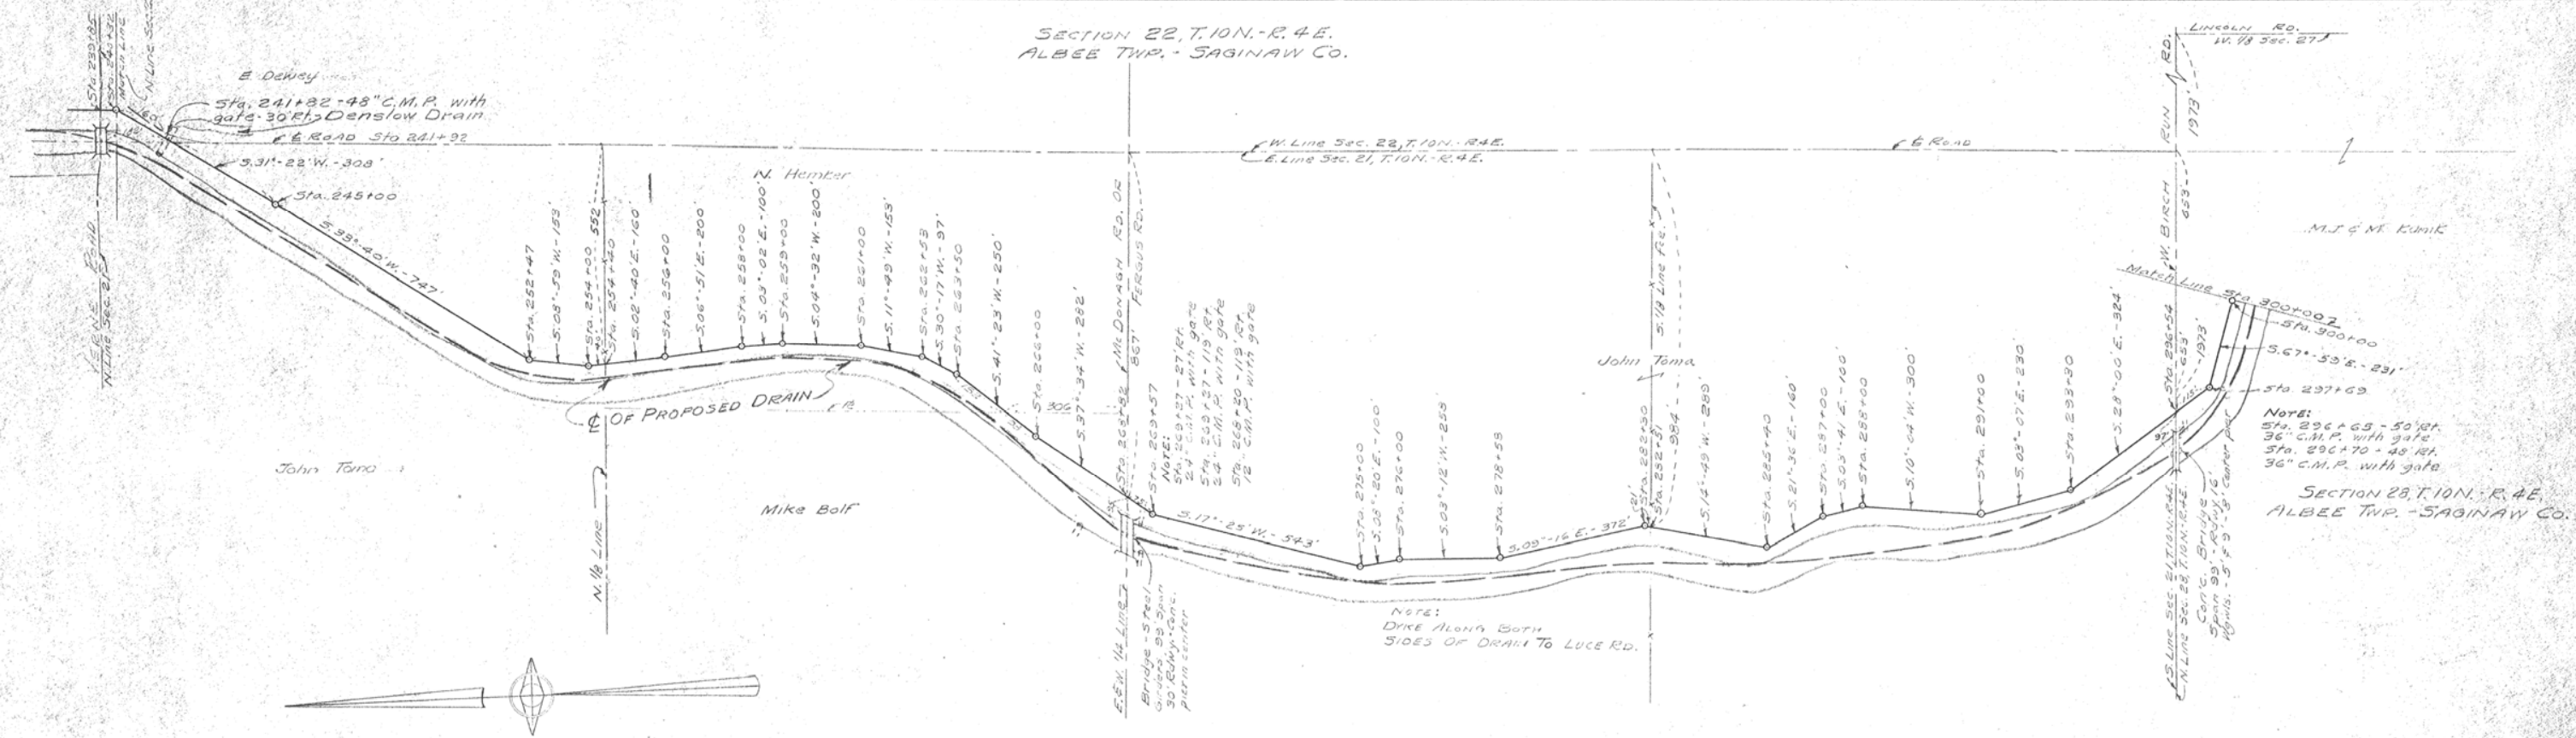

Station stakes and grade hubs are located to the right or left of the centerline of drain looking upstream as follows: Sta 241+92 to Sta. 297+69 74' left

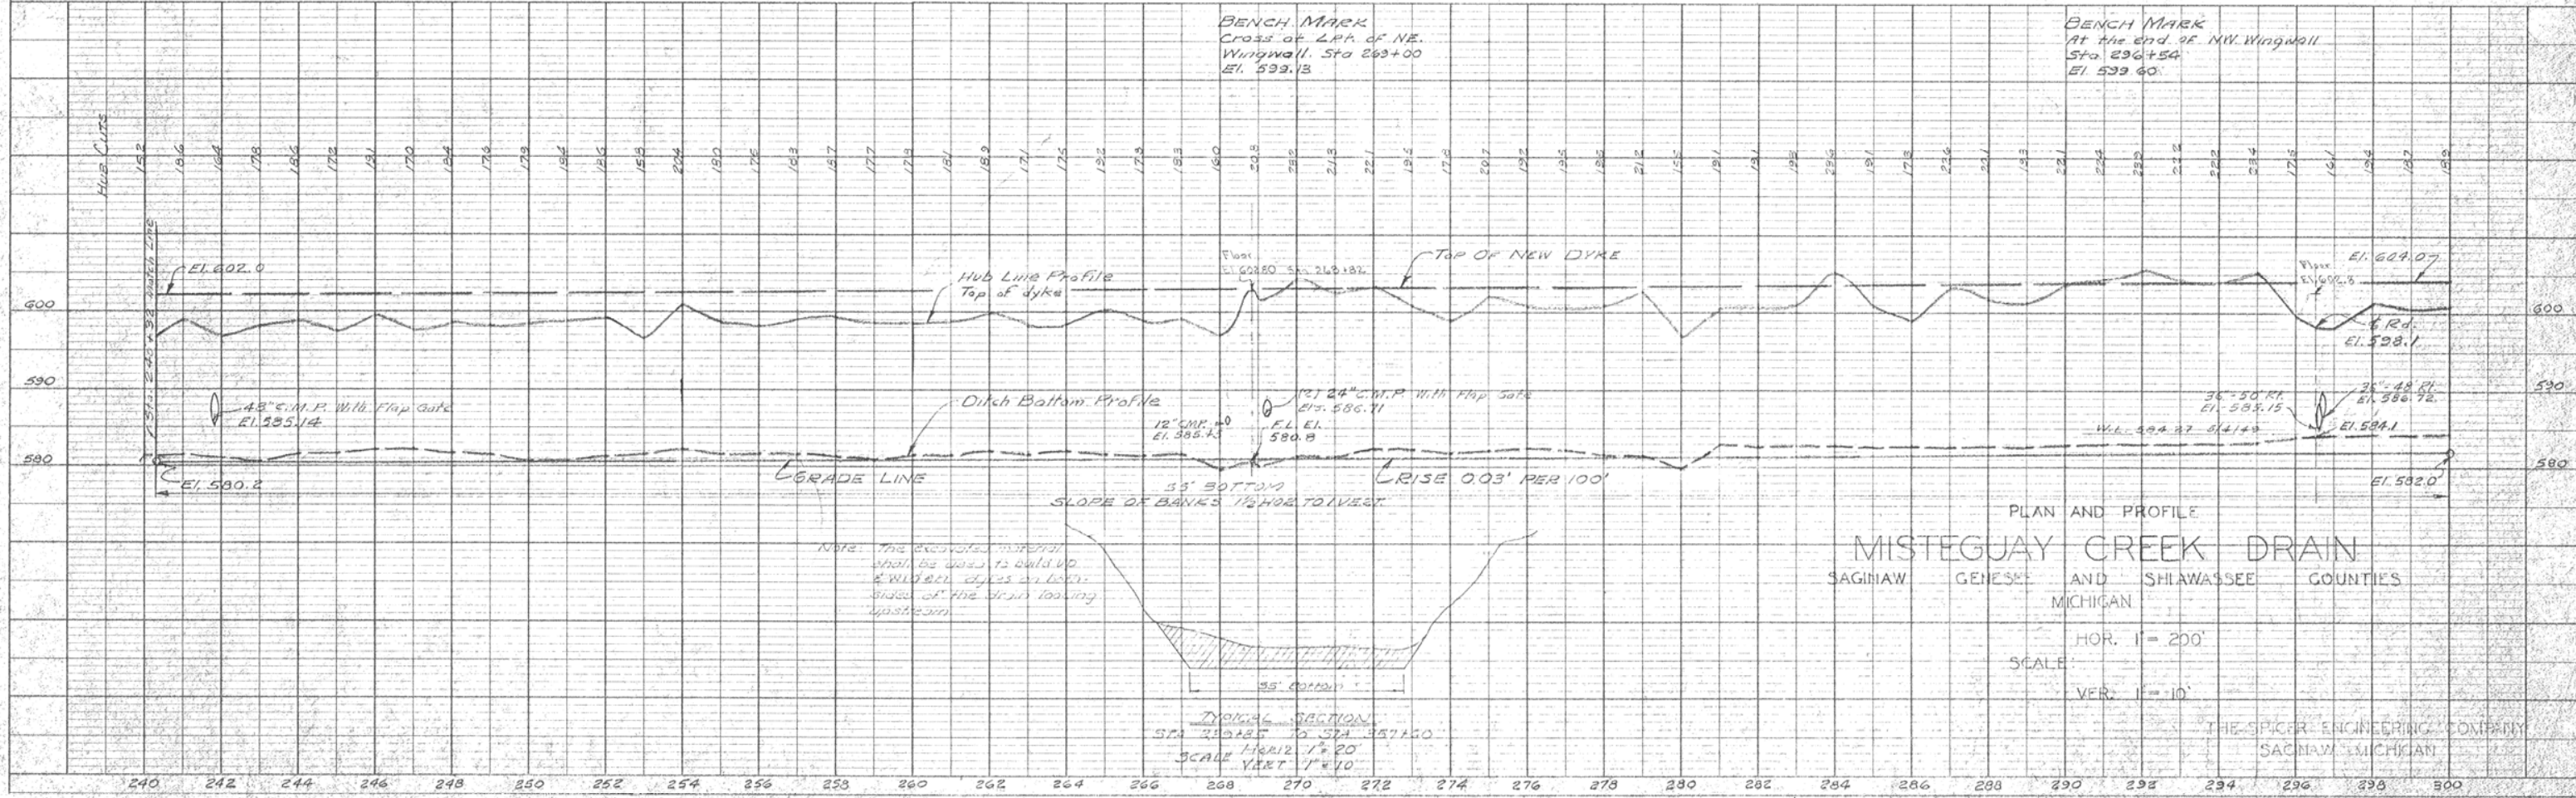

PLAN AND PROFILE
MISTEGUJAY CREEK DRAIN
SAGINAW, GENESSE AND SHILWASSEE COUNTIES
MICHIGAN

HOR. 1" = 200'
SCALE
VER. 1" = 10'

THE SPICER ENGINEERING COMPANY
SAGINAW, MICHIGAN